


3/6/2019 3:20:03 PM \\gensler\projects\Renovation\0224\02490000_SEARS BUILDING_Central_RTR_Layor_mccormick@gnslr.com.rvt

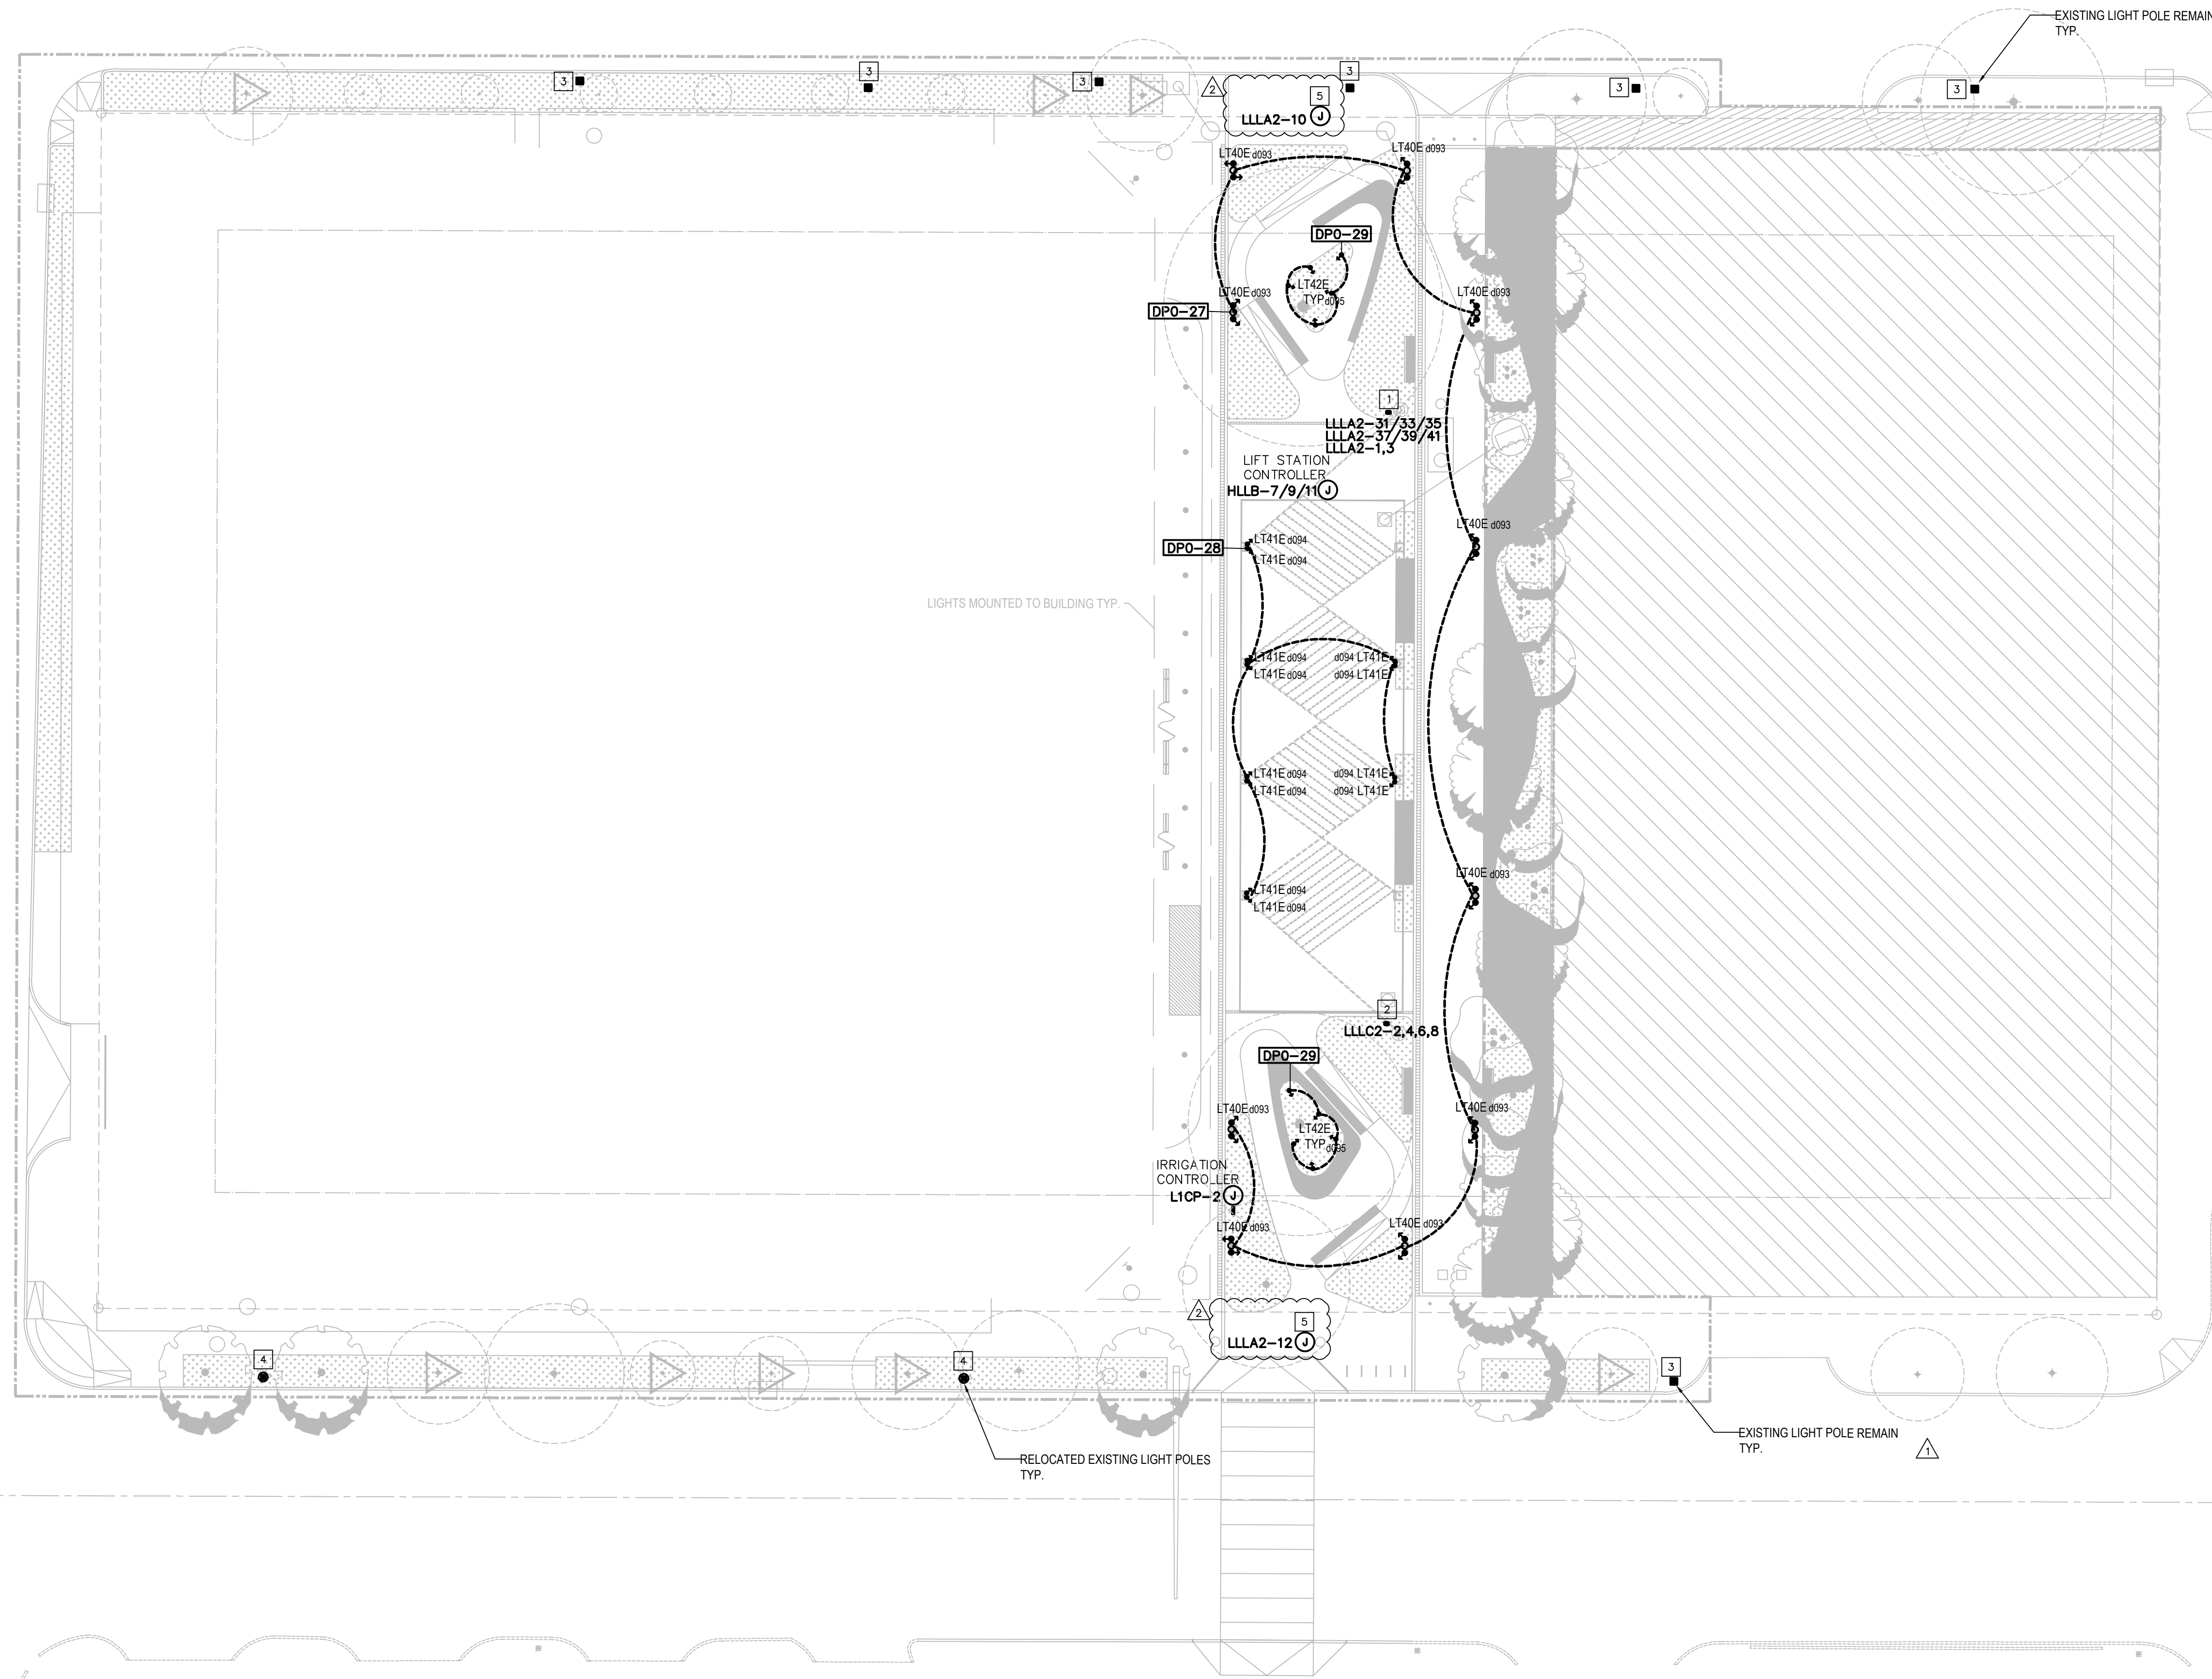

- 1** ELECTRICAL SUBCONTRACTOR SHALL PROVIDE 'COLE LIGHTING' POWER PEDESTAL: WEATHERPROOF, IN-USE WET LOCATION PEDESTAL BOX WITH TWO (2) GFCI WEATHER-RESISTANT DUPLEX RECEPTACLES AND TWO (2) NEMA L21-30R RECEPTACLES. MODEL #TL410-WCS-PED-9/(2)GFCI-9/(2)L21-30R-PED/ADA-CC (RAL 9011 - BLACK) WITH MANUFACTURER ADDED CHEM FILM SURFACE PROTECTIVE TREATMENT. THE L21-30R RECEPTACLES SHALL BE FURNISHED AND INSTALLED SEPARATELY BY THE ELECTRICAL SUBCONTRACTOR. REFER TO LANDSCAPE CONSULTANT'S DRAWINGS FOR LOCATION, ORIENTATION AND MOUNTING REQUIREMENTS.
- 2** ELECTRICAL SUBCONTRACTOR SHALL PROVIDE 'COLE LIGHTING' POWER PEDESTAL: WEATHERPROOF, IN-USE WET LOCATION PEDESTAL BOX WITH FOUR (4) GFCI WEATHER-RESISTANT DUPLEX RECEPTACLES. MODEL #TL410-WCS-PED-9/(4)GFCI-PED/ADA-CC (RAL 9011 - BLACK) WITH MANUFACTURER ADDED CHEM FILM SURFACE PROTECTIVE TREATMENT. REFER TO LANDSCAPE CONSULTANT'S DRAWINGS FOR LOCATION, ORIENTATION AND MOUNTING REQUIREMENTS.
- 3** EXISTING LIGHT POLE TO REMAIN
- 4** EXISTING LIGHT POLE TO BE RELOCATED. REFER TO LANDSCAPE DRAWINGS FOR ADDITIONAL INFORMATION.
- 5** PROVIDE (1) 1" TC FOR POWER TO MONUMENT SIGN. COORDINATE EXACT LOCATION WITH GRAPHICS CONSULTANT.

GENERAL NOTES

ION
4201 Main St, Houston, TX 77002

RICE MANAGEMENT COMPANY
Houston, TX 77005

HR&A ADVISORS, INC.
99 Hudson St., 3rd Floor
New York, NY 10013
Tel 212.977.5597

HINES
2800 Post Oak Blvd.
Houston, TX 77056
Tel 713.621.8000

GENSLER
711 Louisiana St., ST. 300
Houston, TX 77002
Tel 713.844.0000

SHOP ARCHITECTS
233 Broadway, 11th Floor
New York, New York 10279
Tel 212.889.9005

JAMES CARPENTER DESIGN ASSOCIATES INC.
145 Hudson Street.
New York, New York 10018
Tel 212.431.4318

KIMELY HORN
11700 Katy Freeway, Suite
Houston, Texas 77079
Tel 281.597.9300

JAMES CORNER FIELD OPERATIONS
475 Tenth Avenue, 9th Floor
New York, New York 10018
Tel 212.433.1450

WALTER P. MOORE
1301 McKinney, Suite 1100
Houston, Texas 77010
Tel 713.630.7300

I.A. NAMAN + ASSOCIATES
2 Greenway Plaza, Suite 700
Houston, Texas 77046
Tel 713.860.3600
Fax 713.860.3799

HMA Consulting
5010 Wright Road, Suite 150
Stafford, Texas 77477
Tel 832.944.6020

ONE LUX STUDIO
158 West 29th Street, 10th Floor
New York, New York 10001
Tel 212.201.5790

WC & PARTNERS
8055 East Tufts Avenue
Suite 1320
Denver, Colorado 80237
Tel 303.649.1600

LONGMAN LINDSEY
200 West 41st Street
Suite 1100
New York, NY 10036
Tel 212.315.6400

ATS
430 N. 11th Street
La Porte, Texas 77571
Tel 281.842.9591

Date	Description
03/08/2019	DESIGN DEVELOPMENT
04/11/2019	25% CONSTRUCTION DOCUMENTS
06/07/2019	ISSUE FOR PERMIT AND CONSTRUCTION
10/25/2019	BULLETIN 06
2/09/16/2020	BULLETIN 14

Seal / Signature

NOT FOR CONSTRUCTION

Project Name: _____

ION

Project Number: 002.8499.000

Description: ELECTRICAL SITE PLAN

Scale: 1" = 20'-0"

E01.000